


↑
MINNEAPOLIS

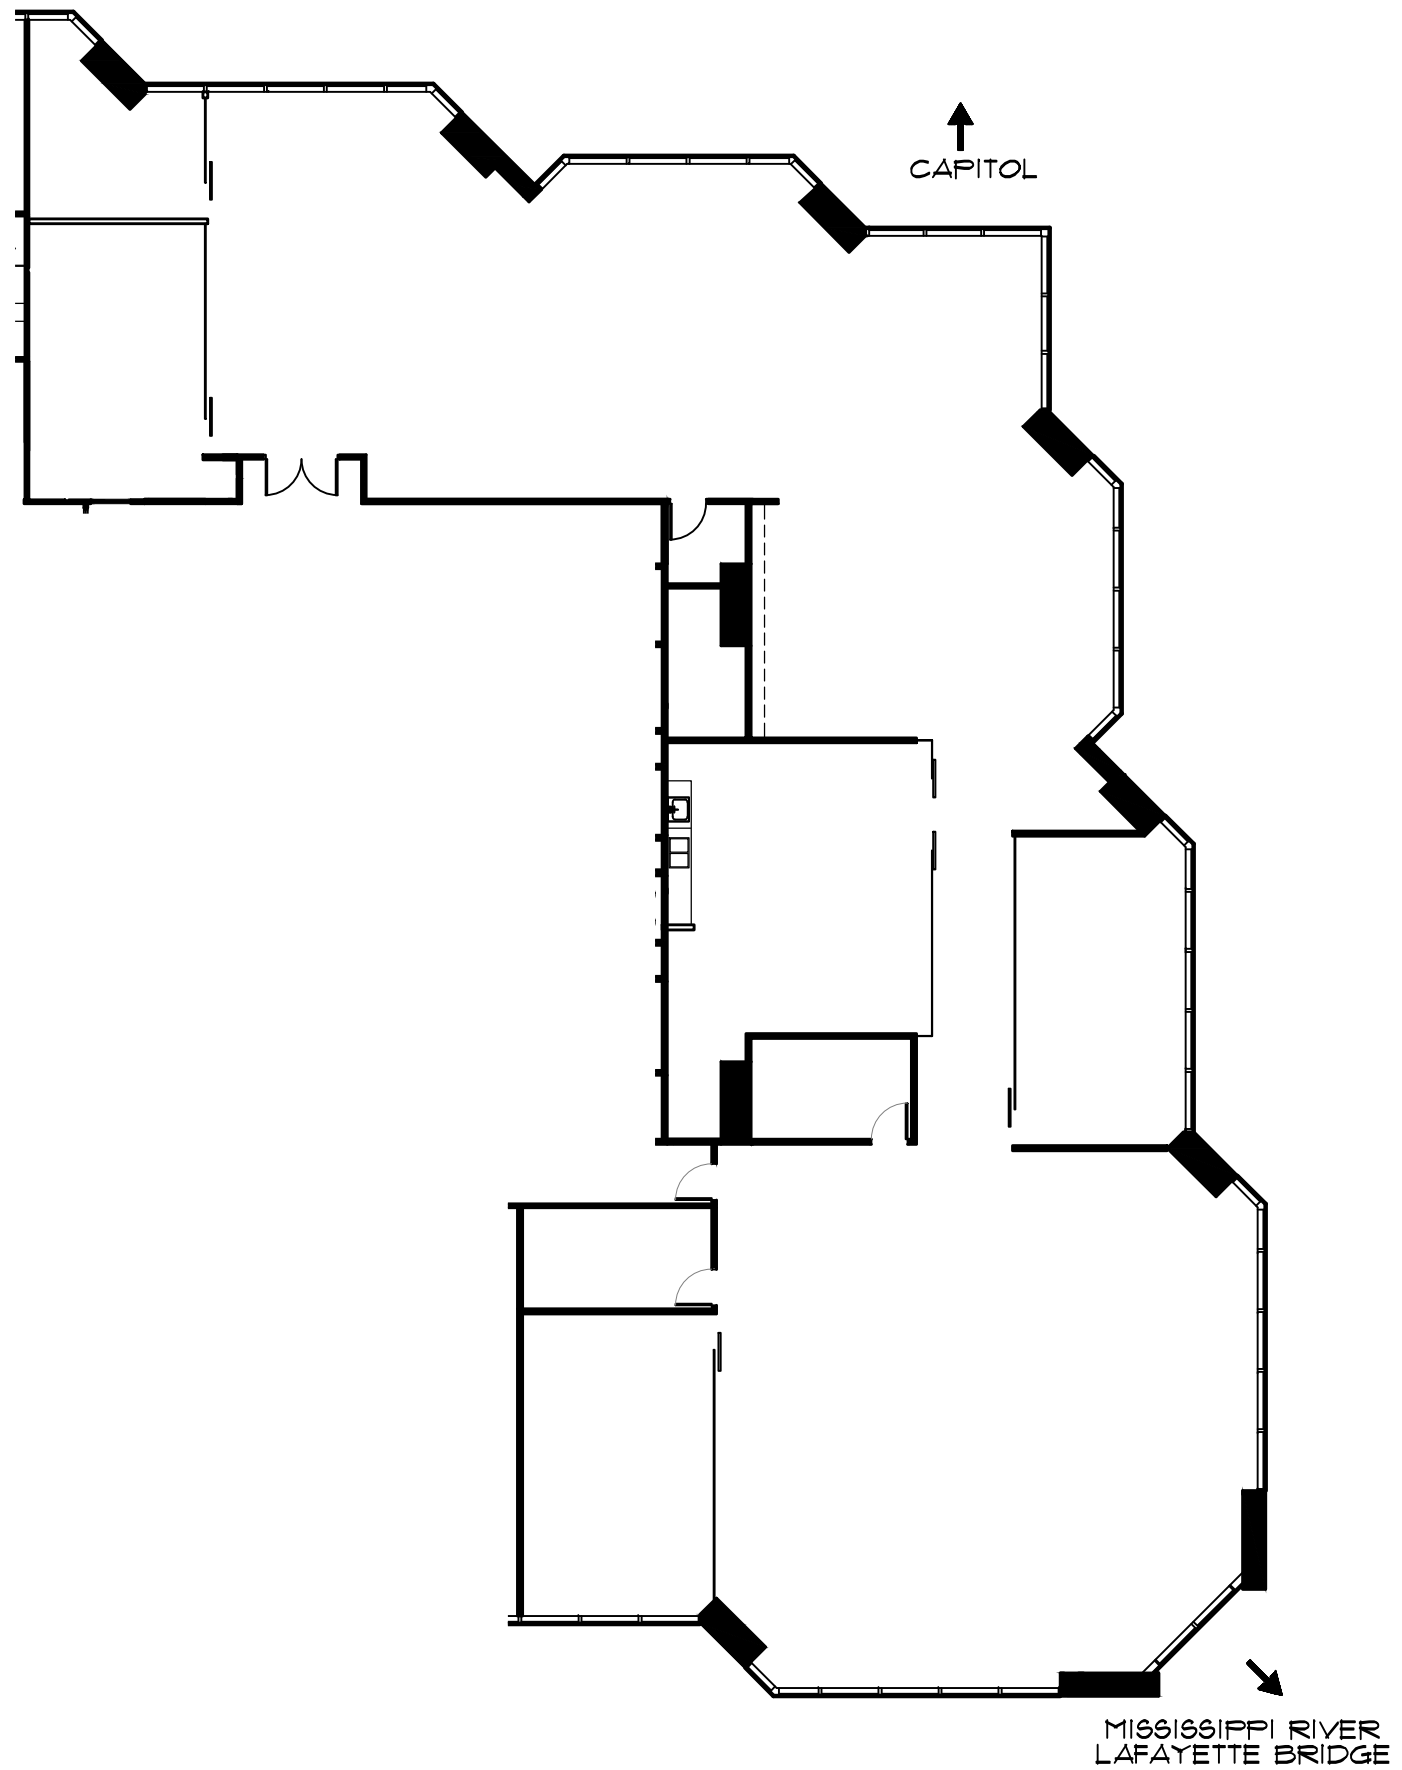


10 south eighth street
minneapolis, mn
55402

T 612 339 2257
F 612 349 2930

www.shealink.com



UNILEV MANAGEMENT CORP

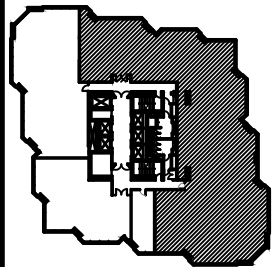

KEY PLAN
**AS-BUILT
FLOOR PLAN**
FLOOR 30
SUITE #3000
AGRIBANK

8,337 RSF

comm. no.: 6370.01
scale: 1/16" = 1'-0"
date: 02.08.17
revision date:
drawn by:

AB-3000