


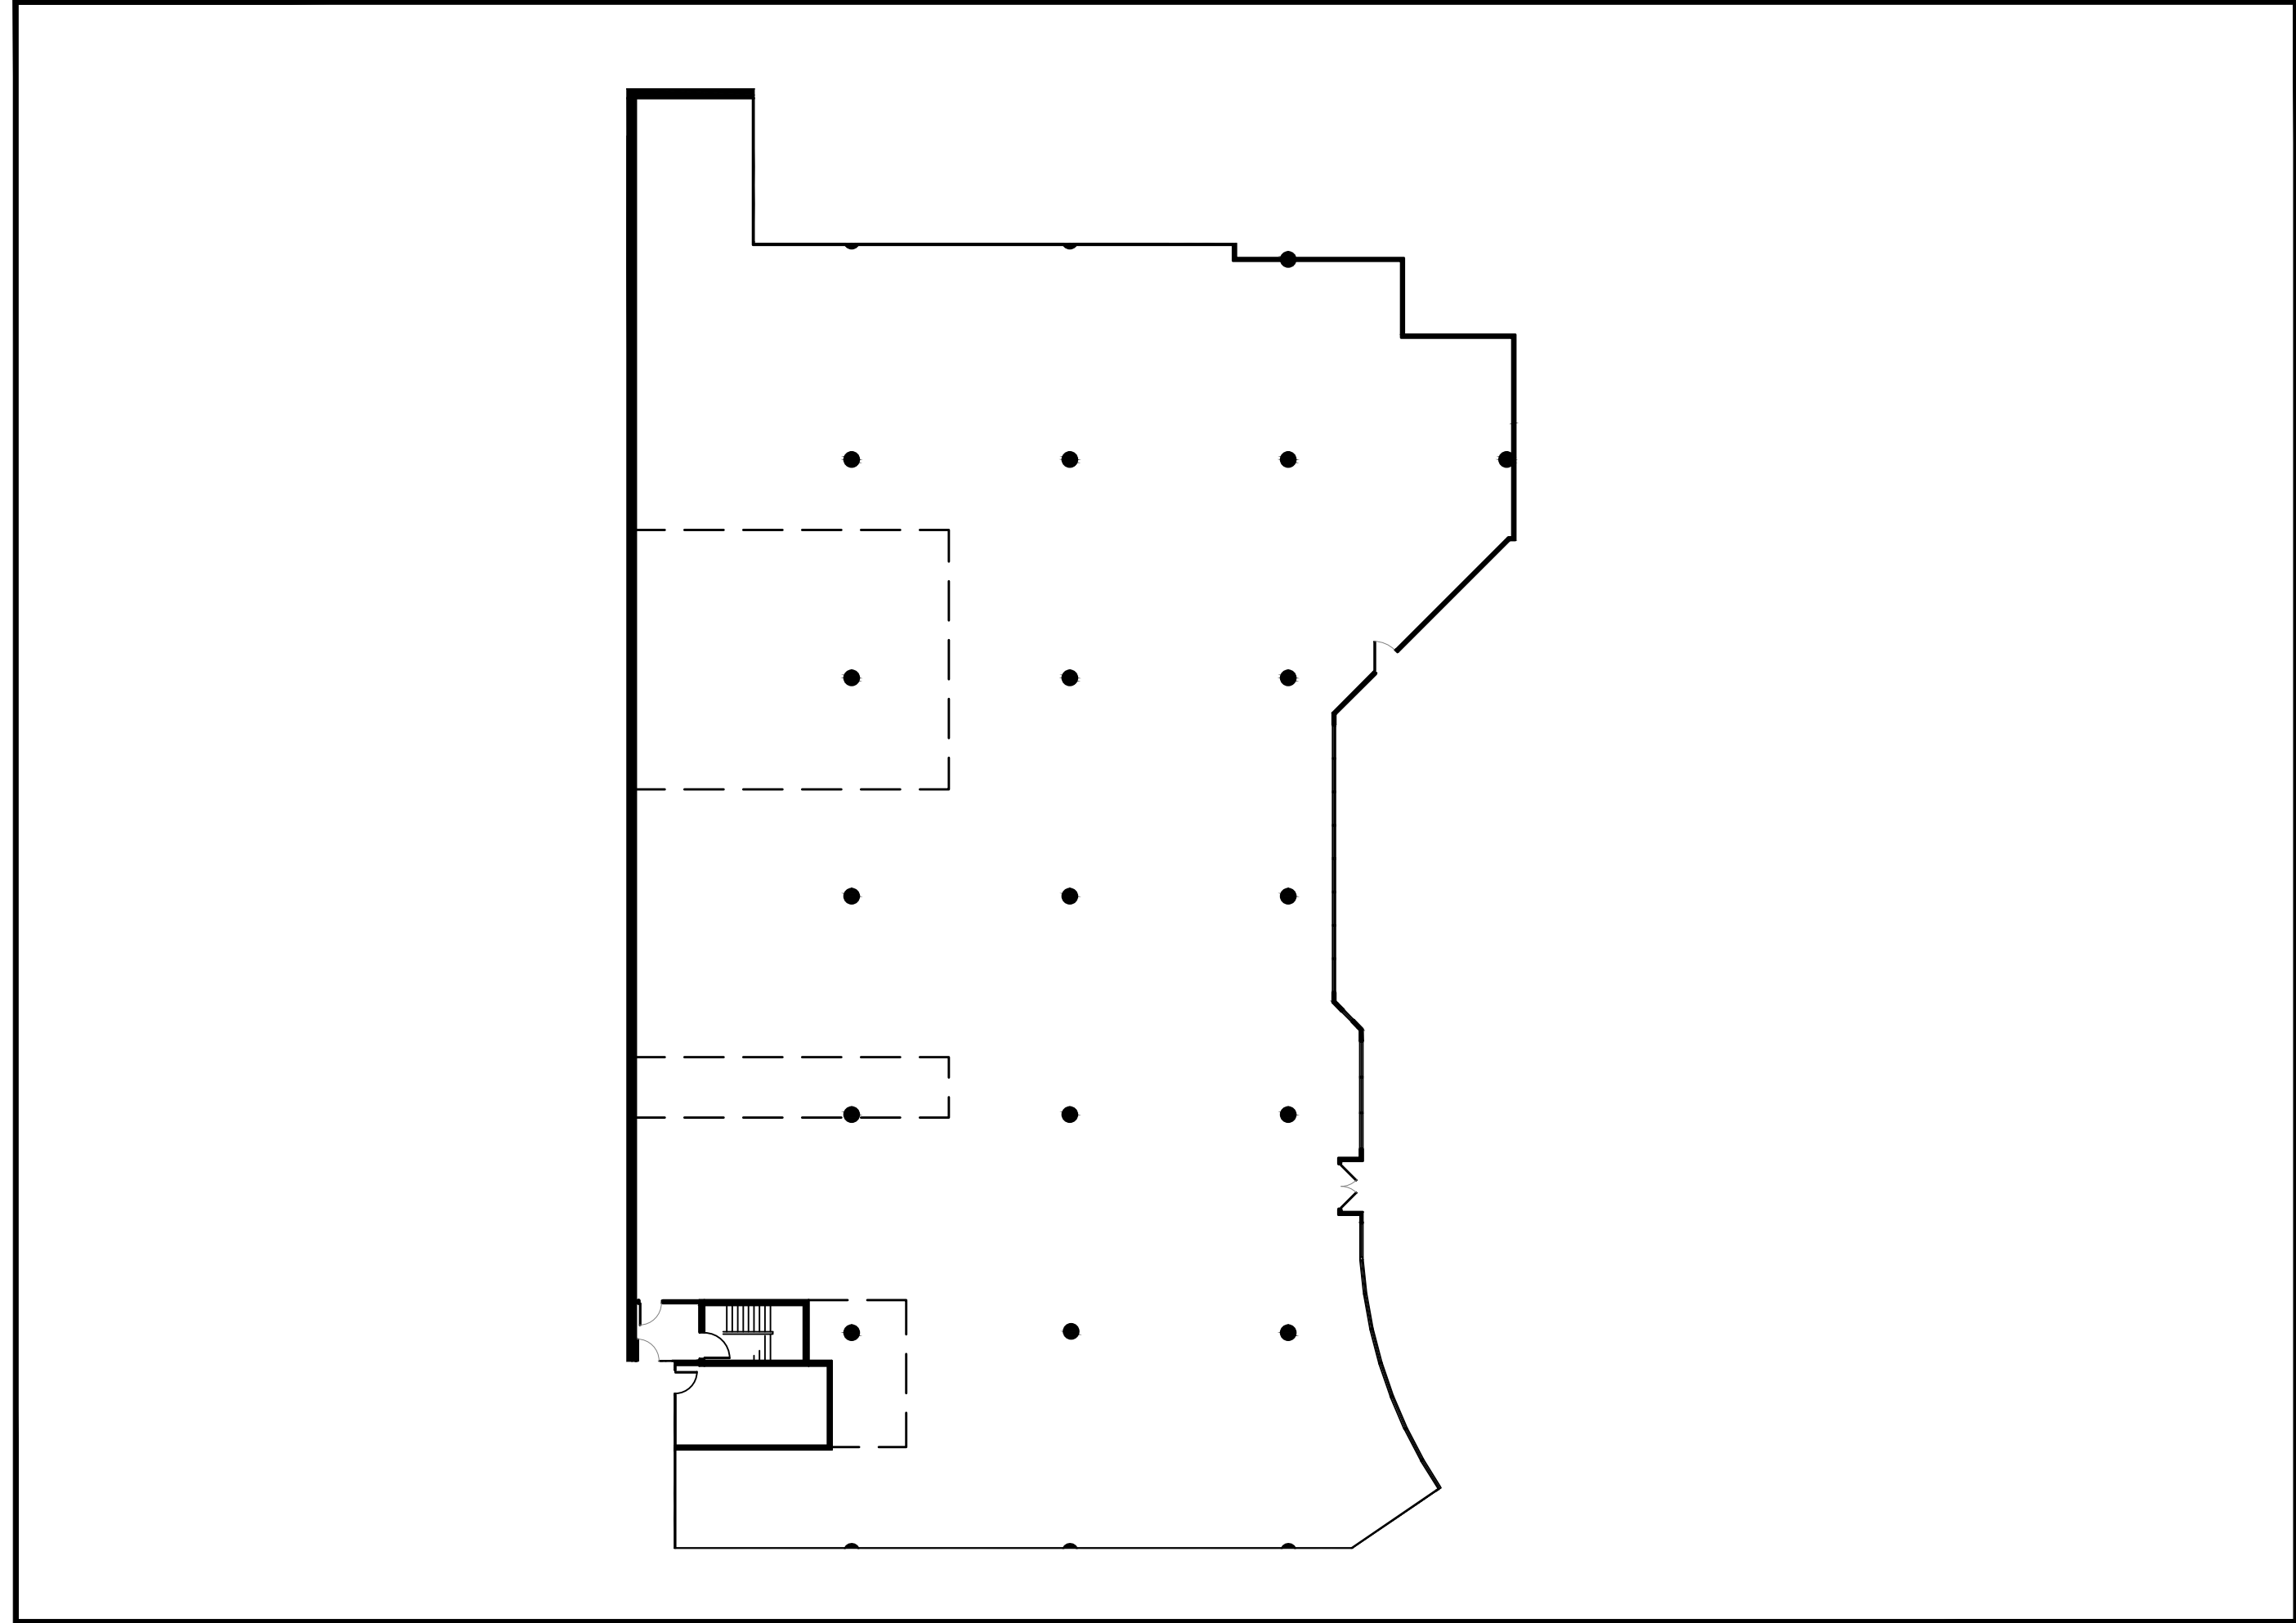


100 north sixth street
suite 650c
minneapolis, mn
55403-1594

T 612 339 2257
F 612 349 2930

www.shealink.com



UNILEV MANAGEMENT CORP

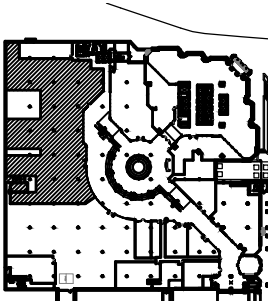

KEY PLAN

**AS-BUILT
FLOOR PLAN
FLOOR 1
SUITE #100
AGRIBANK
16,275 USF
18,212 RSF**

comm. no.: 6370.01

scale: NOT TO SCALE

date: 3.21.11

revision date:

drawn by:

AB-100